



PLAN — KITCHEN ISLAND + VENTILATION

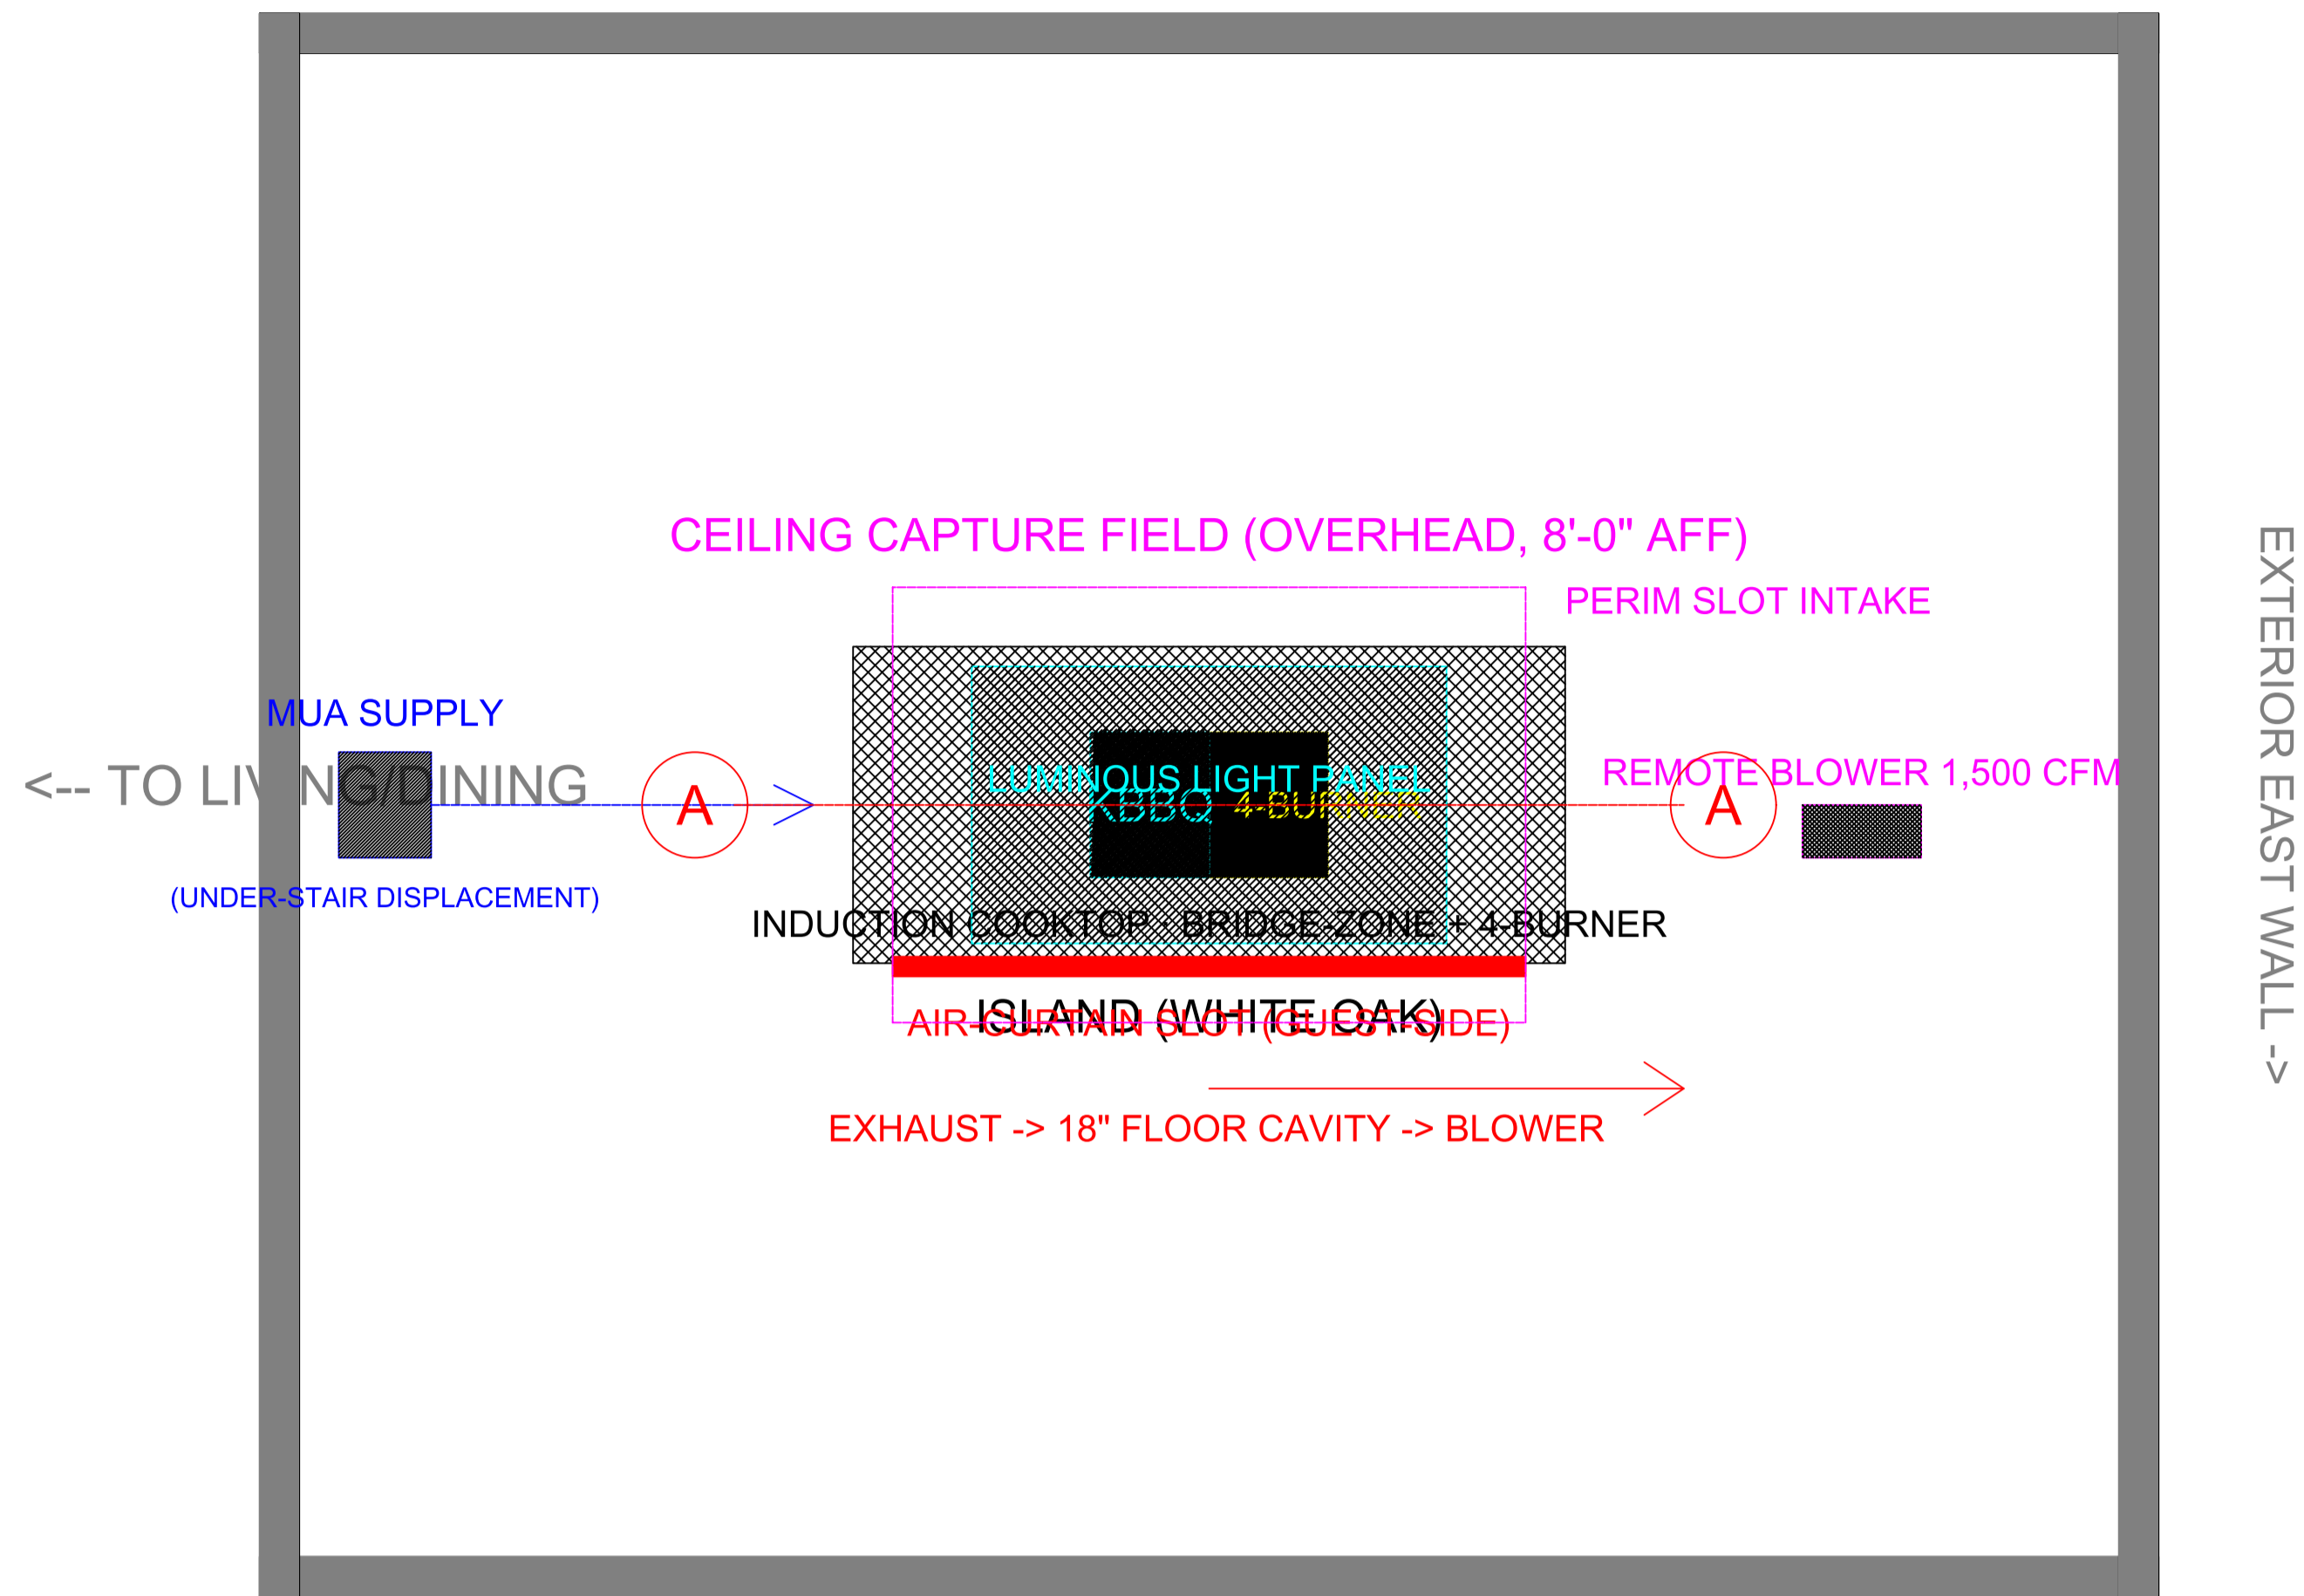

SECTION A-A — THROUGH ISLAND COOKING SYSTEM

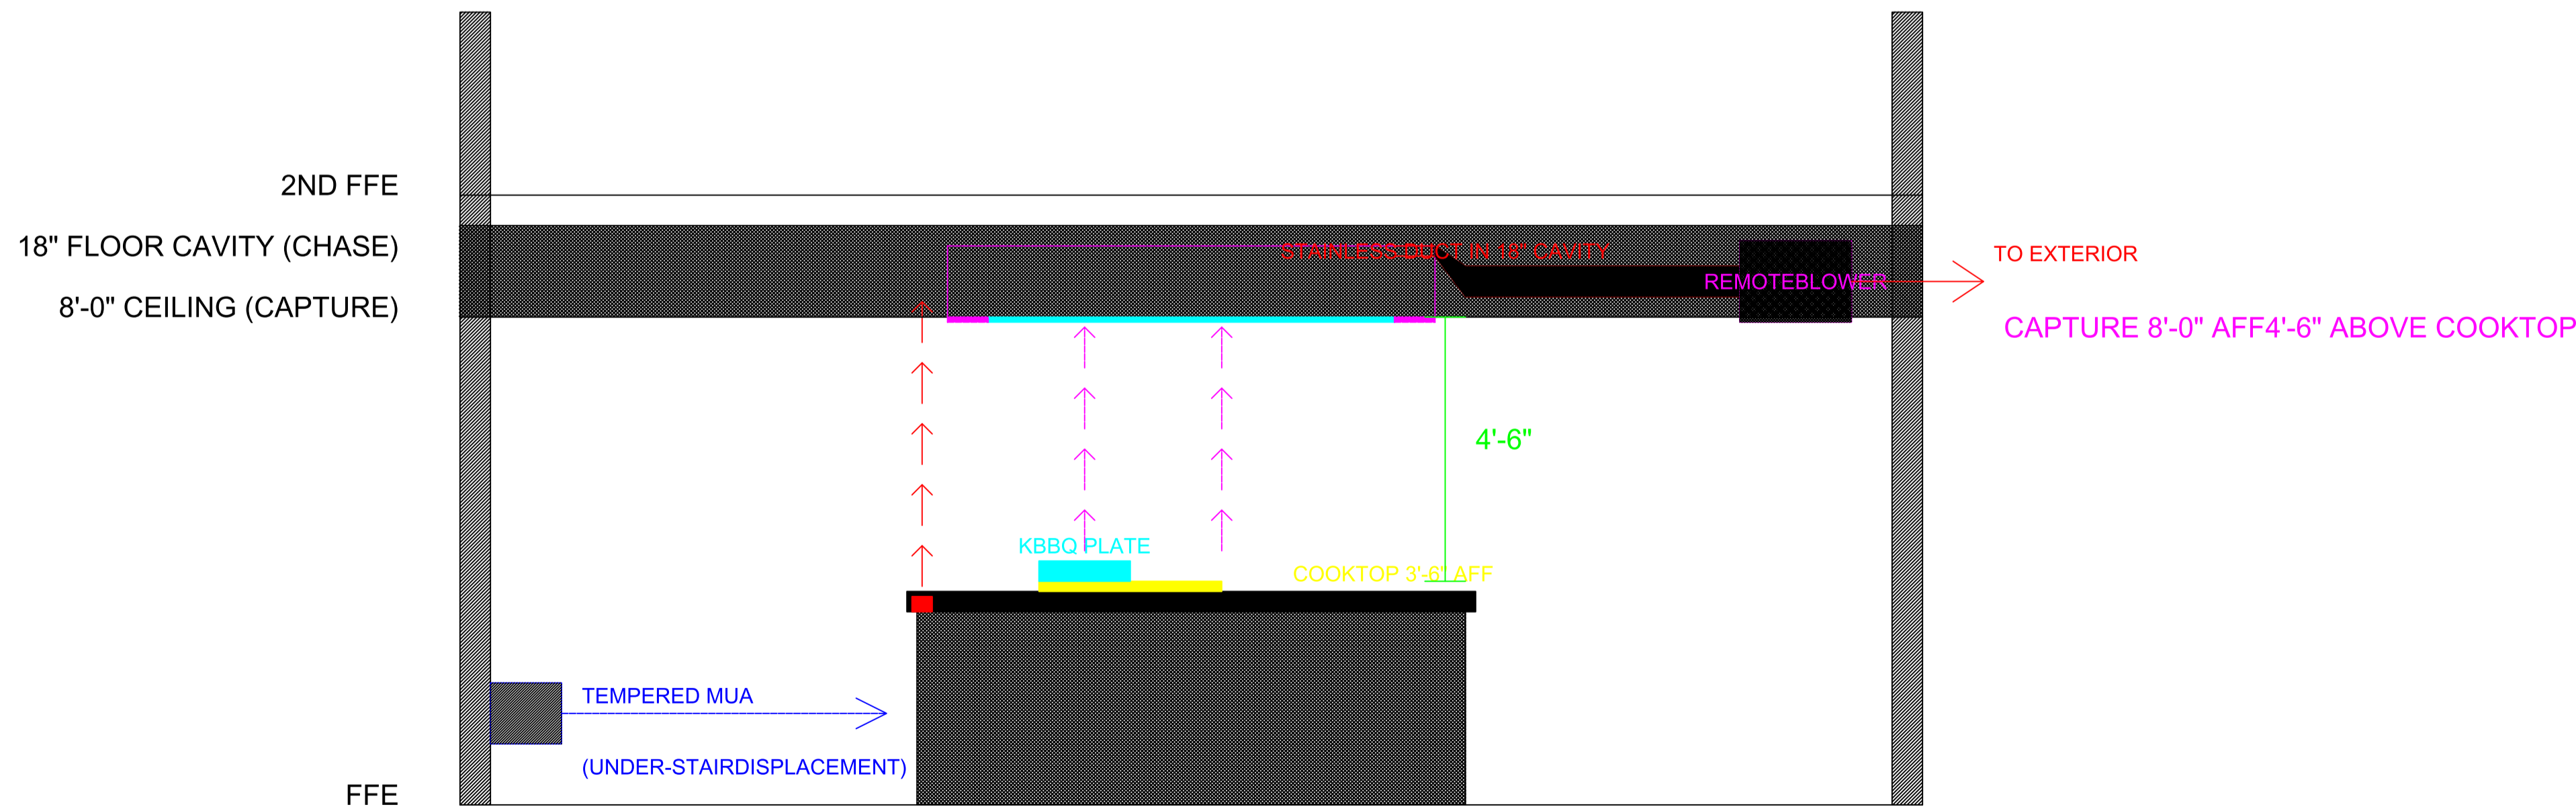

BARNDOMINIUM

LDD-07 - COOKING + ISLAND VENTILATION PLAN + SECTION

SHEET A-307 SCALE 3/8" = 1'-0"

2026-05-17 BY SpicyRiceCakes