


# MIDDLE CLUSTER · WET-WALL SECTION

(see plan view for N/S/Middle cluster locations)

MONOPITCH ROOF (slope east)

2" VENT TO SKY · ROOF PENETRATION

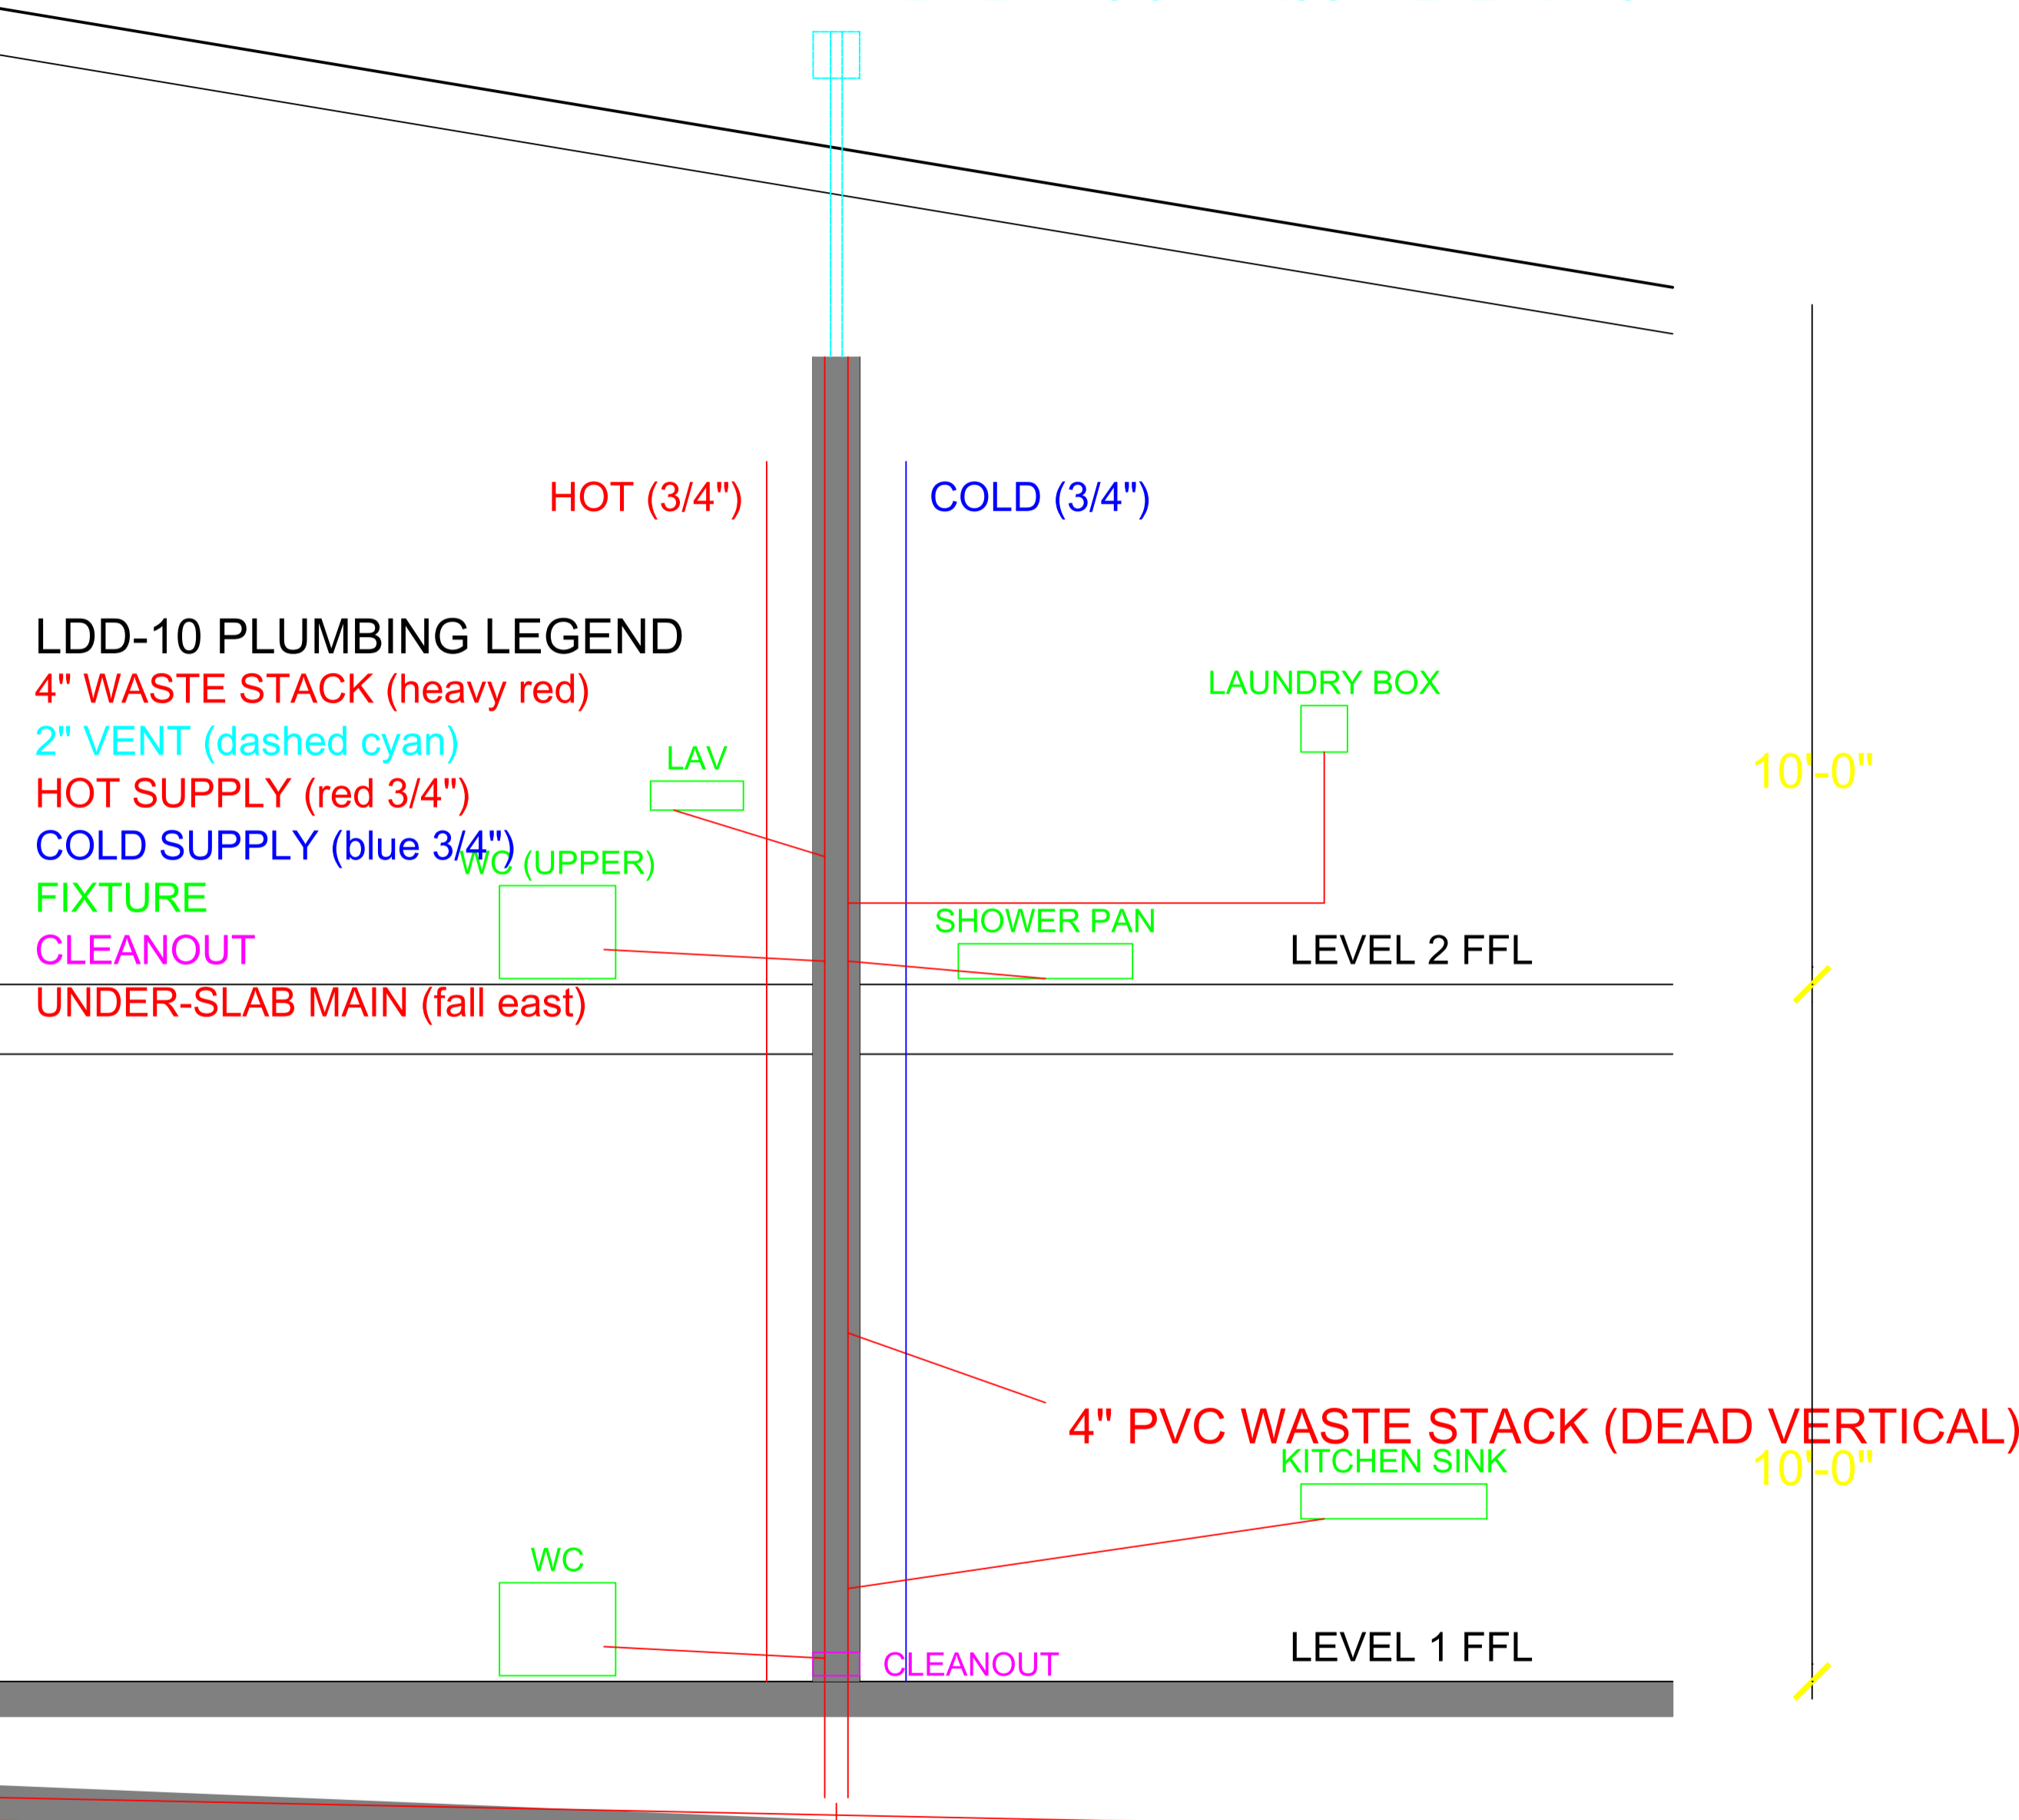

## LDD-10 PLUMBING LEGEND

4" WASTE STACK (heavy red)

2" VENT (dashed cyan)

HOT SUPPLY (red 3/4")

COLD SUPPLY (blue 3/4")

FIXTURE

CLEANOUT

UNDER-SLAB MAIN (fall east)

10'-0"

10'-0"

4" MAIN DRAIN · FALL 1/8"/FT EAST → SITE SEWER

BARNDOMINIUM

LDD-10 · PLUMBING · MIDDLE CLUSTER WET-WALL SECTION

SHEET A-301 SCALE 3/8" = 1'-0"

2026-05-17 BY SpicyRiceCakes